




Chris Harris
Licensed Real Estate Salesperson
022 587 9179





Chris Harris
 Licensed Real Estate Salesperson
 022 587 9179






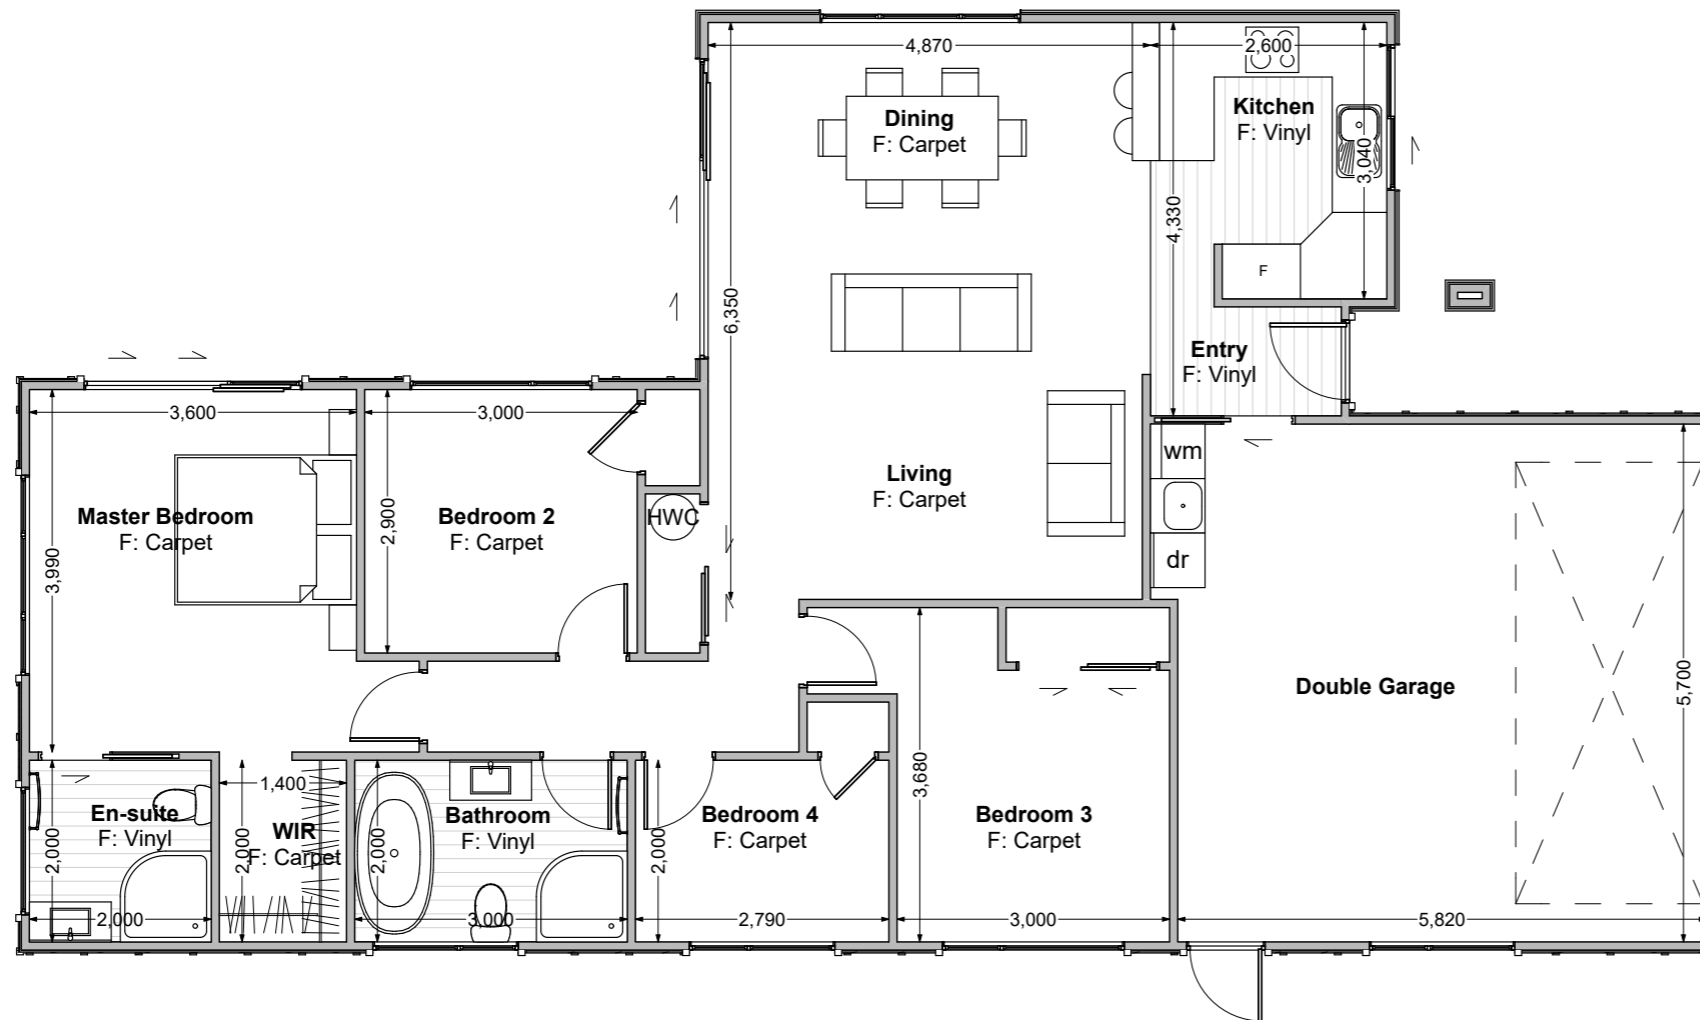


Floor Area = 146m²

- Cladding 1 = Linea Weatherboards on cavity
- Cladding 2 = Board and Batten on cavity
- Roofing = Corrugated Colorsteel

Chris Harris
Licensed Real Estate Salesperson
022 587 9179

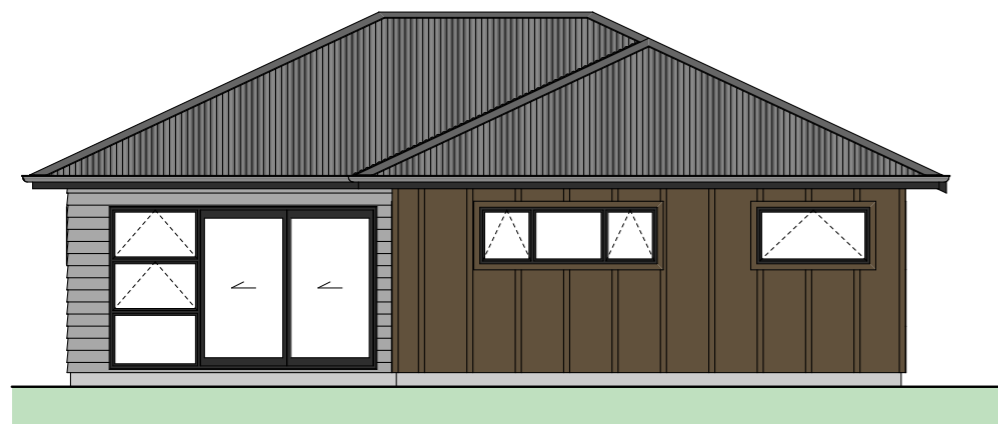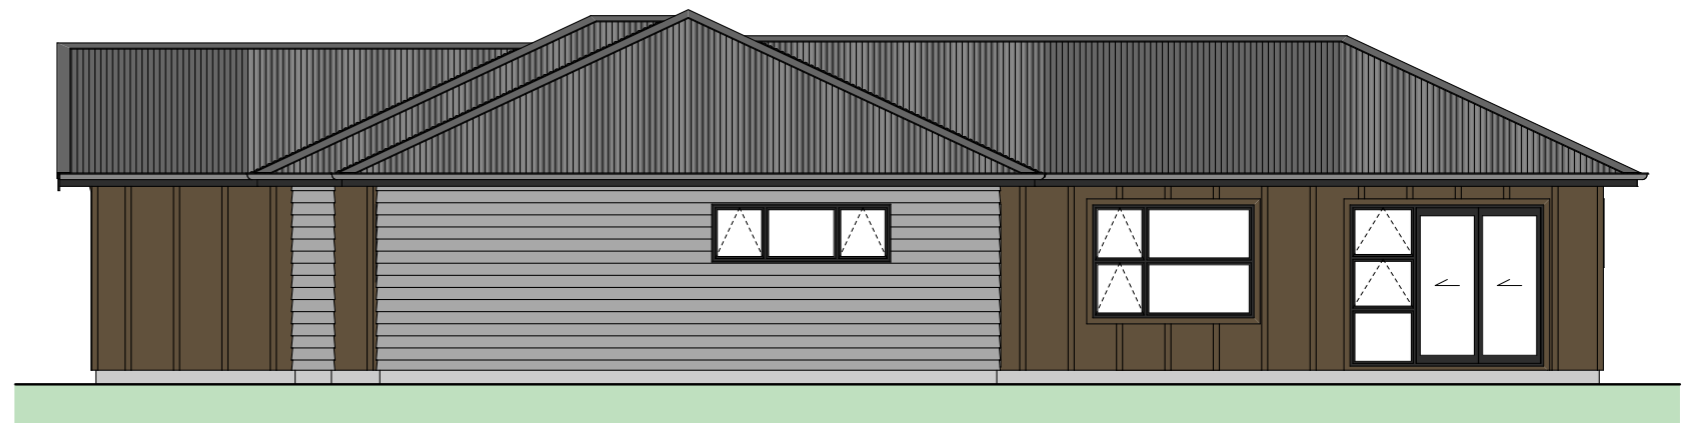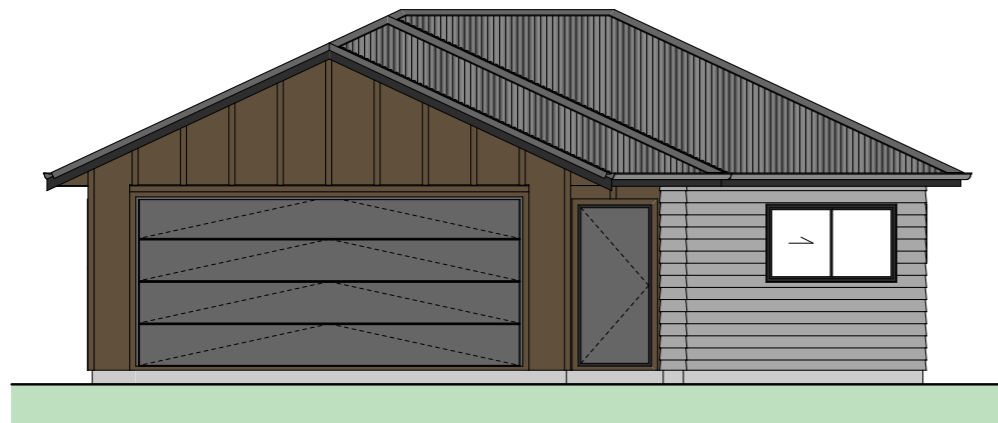


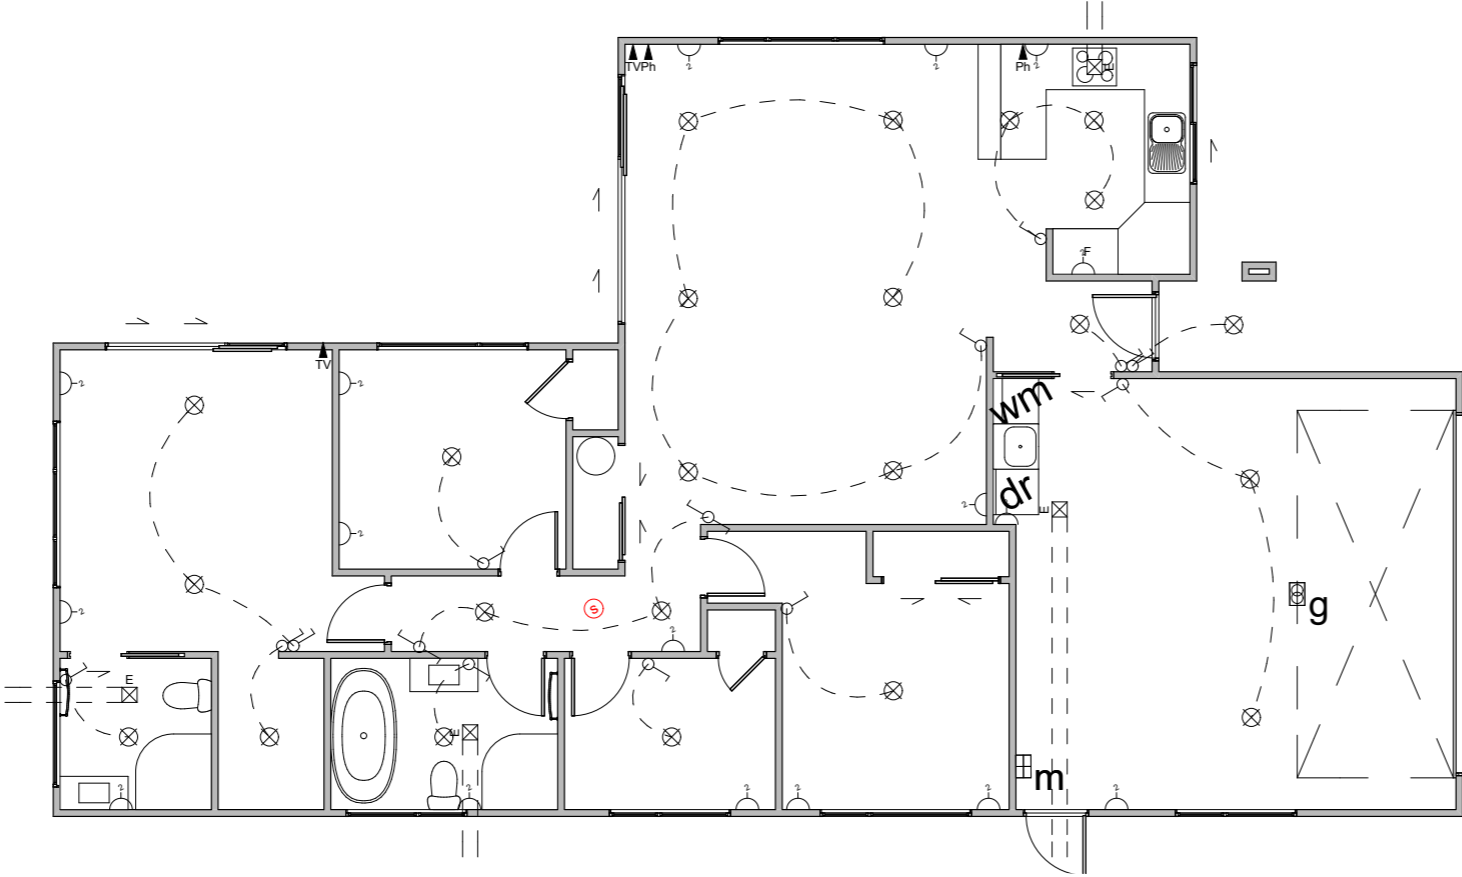


Electrical Legend

- Light switch
- ⌘ Two way light switch
- Feature light
- ⊗ External wall light
- ⊗ Recessed downlight
- Fluorecent light
- ⌘ Power point
- ⊞m Meter box
- ⊞d Distribution board
- ⊞g Garage door motor
- ⊞ Smoke detector
- ⊞= Extractor fan
- ⊞ Phone outlet
- ⊞ Television outlet

Chris Harris
Licensed Real Estate Salesperson
022 587 9179



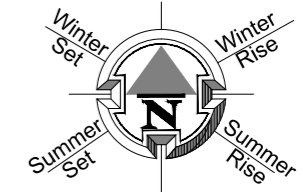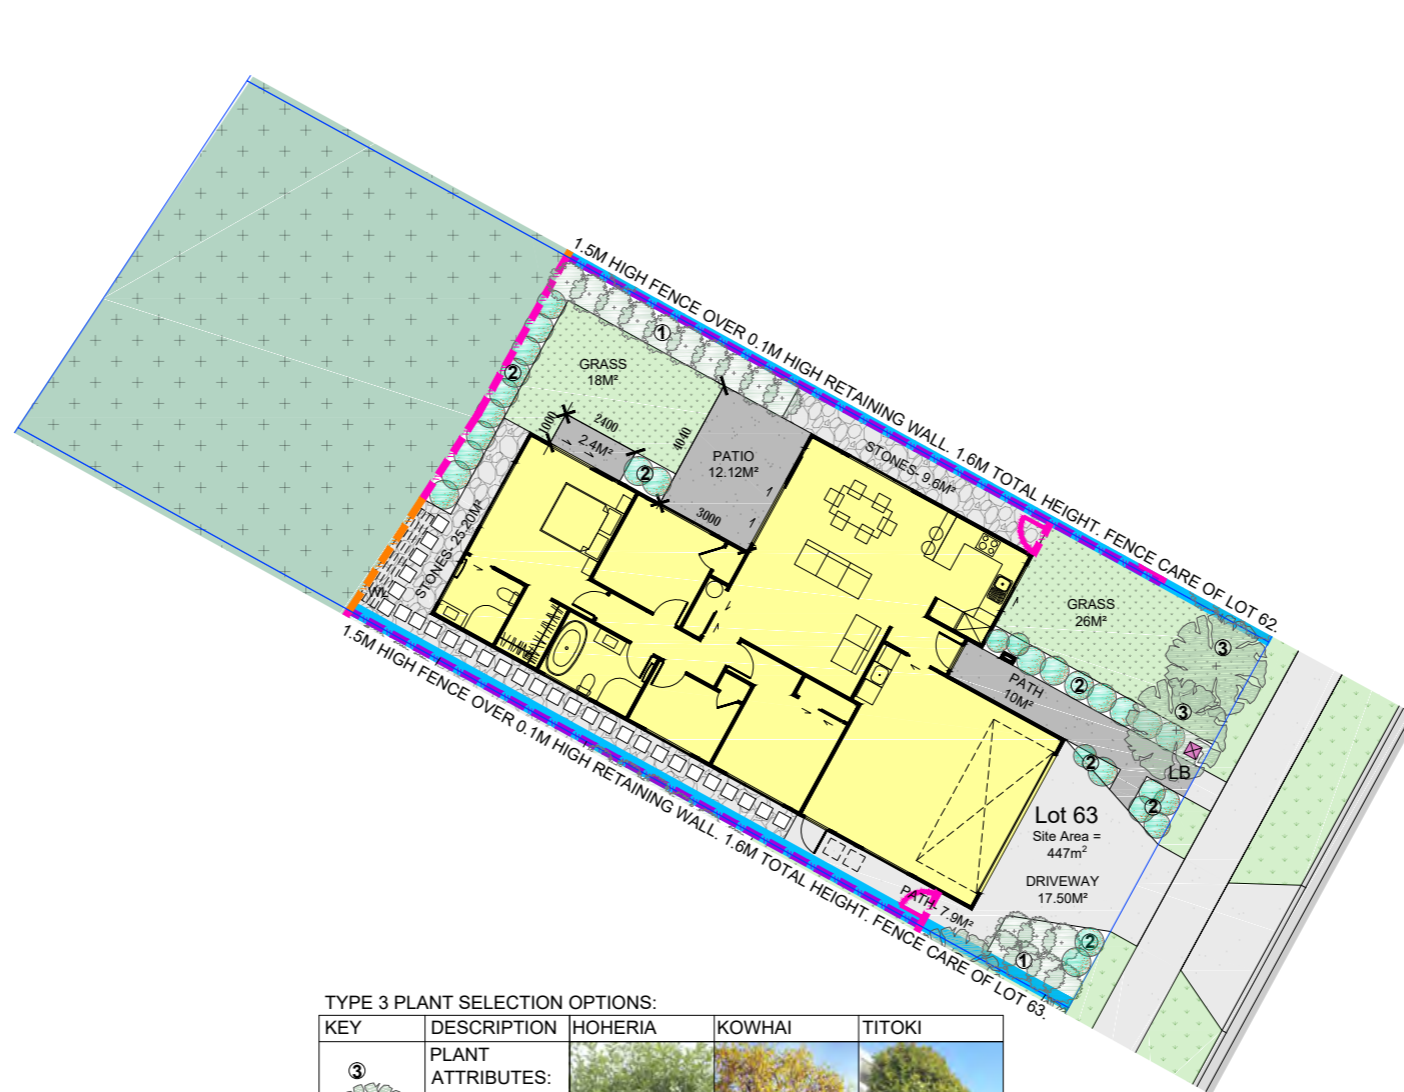

LEGEND	
	GRASS. HYDROSEED WITH 100MM TOPSOIL.
	BRUSHED FINISH CONCRETE.
	CONCRETE: EXPOSED AGGREGATE FINISH OR COLOURED FINISH OR SAWCUTS AT 0.6M CTRS
	STONES (PERMEABLE)
	STONES (PERMEABLE) WITH FLAGSTONE STEPPING STONES
	INDICATIVE BATTER BANK. REFER SURVEY DOCUMENTS FOR DETAILS.
	SERVICE AREA FOR BINS.
	LETTERBOX
	WASHING LINE
	1.8M HIGH ROUGH SAWN CLOSED BOARDED TIMBER FENCE.
	1.8M HIGH OPEN SLAT TIMBER SCREEN.
	1.5M HIGH HORIZONTAL OPEN SLAT TIMBER FENCE.
	1.2M HIGH HORIZONTAL OPEN SLAT TIMBER FENCE.
	INDICATIVE RETAINING WALL (REFER ENGINEERS DOCUMENTATION).

PRINT IN COLOUR
SCALE 1:200 @ A3
COPYRIGHT © HOUSE OF ORANGE DESIGN LTD

LANDSCAPE SCHEDULE OF AREAS:	
SITE AREA:	447 M ²
PERMEABLE AREA:	254.50 M ² (56.94%)
CONCRETE:	50 M ²
GARDEN:	31 M ²
LAWN:	44 M ²
STONES:	34.80 M ²
FENCE RS 1.8M:	4 LIN. M
SCREEN 1.8M:	- LIN. M
FENCE SLAT 1.5M:	20 LIN. M
FENCE SLAT 1.2M :	11 LIN. M
VEHICULAR CROSSING:	12.10 M ²
- FENCE LENGTH INCLUDES GATE. ALL GATES ARE BLACK POWDERCOATED.	
- 100X50 H5 GARDEN EDGING.	
- ALL RETAINING WALLS, BATTER BANKS, M ² AREAS, FENCING HEIGHTS AND LENGTHS ARE SUBJECT TO FINAL FINISHED GROUND LEVEL HEIGHT AND EARTHWORKS PLAN AND ARE SUBJECT TO CHANGE.	

NZ COUNTRY GARDEN

TYPE 1 PLANT SELECTION OPTIONS:

KEY	DESCRIPTION	AKE AKE	GRISELINIA	PITTOSPORUM
①	PLANT ATTRIBUTES: - EVERGREEN - HEDGING SELECTION			

TYPE 3 PLANT SELECTION OPTIONS:

KEY	DESCRIPTION	HOHERIA	KOWHAI	TITOKI
③	PLANT ATTRIBUTES: - NZ NATIVE - FEATURE TREE			

TYPE 2 PLANT SELECTION OPTIONS:

KEY	DESCRIPTION	ANEMANTHELE LESSONIANA 'WIND GRASS'	ARTHROPODIUM CIRRATUM 'RENGA RENGA'	COROKIA CULTIVARS	FLAX CULTIVARS	HEBE	LAVENDER	CHOISYA TERNATA 'MEXICAN ORANGE BLOSSOM'	UGNI MOLINAE 'NZ CRANBERRY'	ROSEMARY	VIBURNUM 'EVE PRICE'
②	PLANT ATTRIBUTES: - EVERGREEN - SHRUBS (1M)										

Chris Harris
Licensed Real Estate Salesperson
022 587 9179

Placement	Colour	Sample/notes
Roof	Ebony Corrugated Colorsteel	
Fascia	Titania	
Gutters	Ebony	
Downpipes	Ebony	
Soffites	Enclose ¼ Wattyl	
Joinery	Matt Black	
Cladding 1 - Linea	Cotton Grey Wattyl	
Cladding 2 - Board and Batten	Night Sky Wattyl	
Garage door - colour Profile	Titania Milano Smooth	
Garage revels	Night Sky Wattyl	
Front door - colour Profile	Matt Scoria LT100	
Notes		